


***ขนาดอาคารมีการปรับเปลี่ยนตามหน้างาน



NOTES :

1. THIS DRAWING AND ALL DESIGNS THEREIN ARE THE SOLE PROPERTY OF 7RANGE AND MAY NOT BE USED WITHOUT WRITTEN AUTHORIZATION.
2. THE CONTRACTOR IS TO VERIFY ALL SITE DIMENSIONS AND NOTIFY 7RANGE OF ANY DISCREPANCIES.
3. ALL DISCREPANCIES ARE TO BE REPORTED TO 7RANGE DIMENSIONS ARE NOT TO BE SCALED OFF THIS DRAWING.
4. ALL MEASUREMENT IN MILLIMETERS.
5. ALL COPYRIGHT, DESIGN AND OTHER INTELLECTUAL PROPERTY RIGHTS IN OUR DESIGNS AND PRODUCTS AND IN THE IMAGES, TEXT AND DESIGN BOTH IN THIS DOCUMENT AND WITHIN ANY ATTACHMENTS TO THIS DOCUMENT WILL REMAIN THE PROPERTY OF 7RANGE ANY INFRINGEMENT OF THIS RIGHT WILL BE VIGOROUSLY PURSUED.

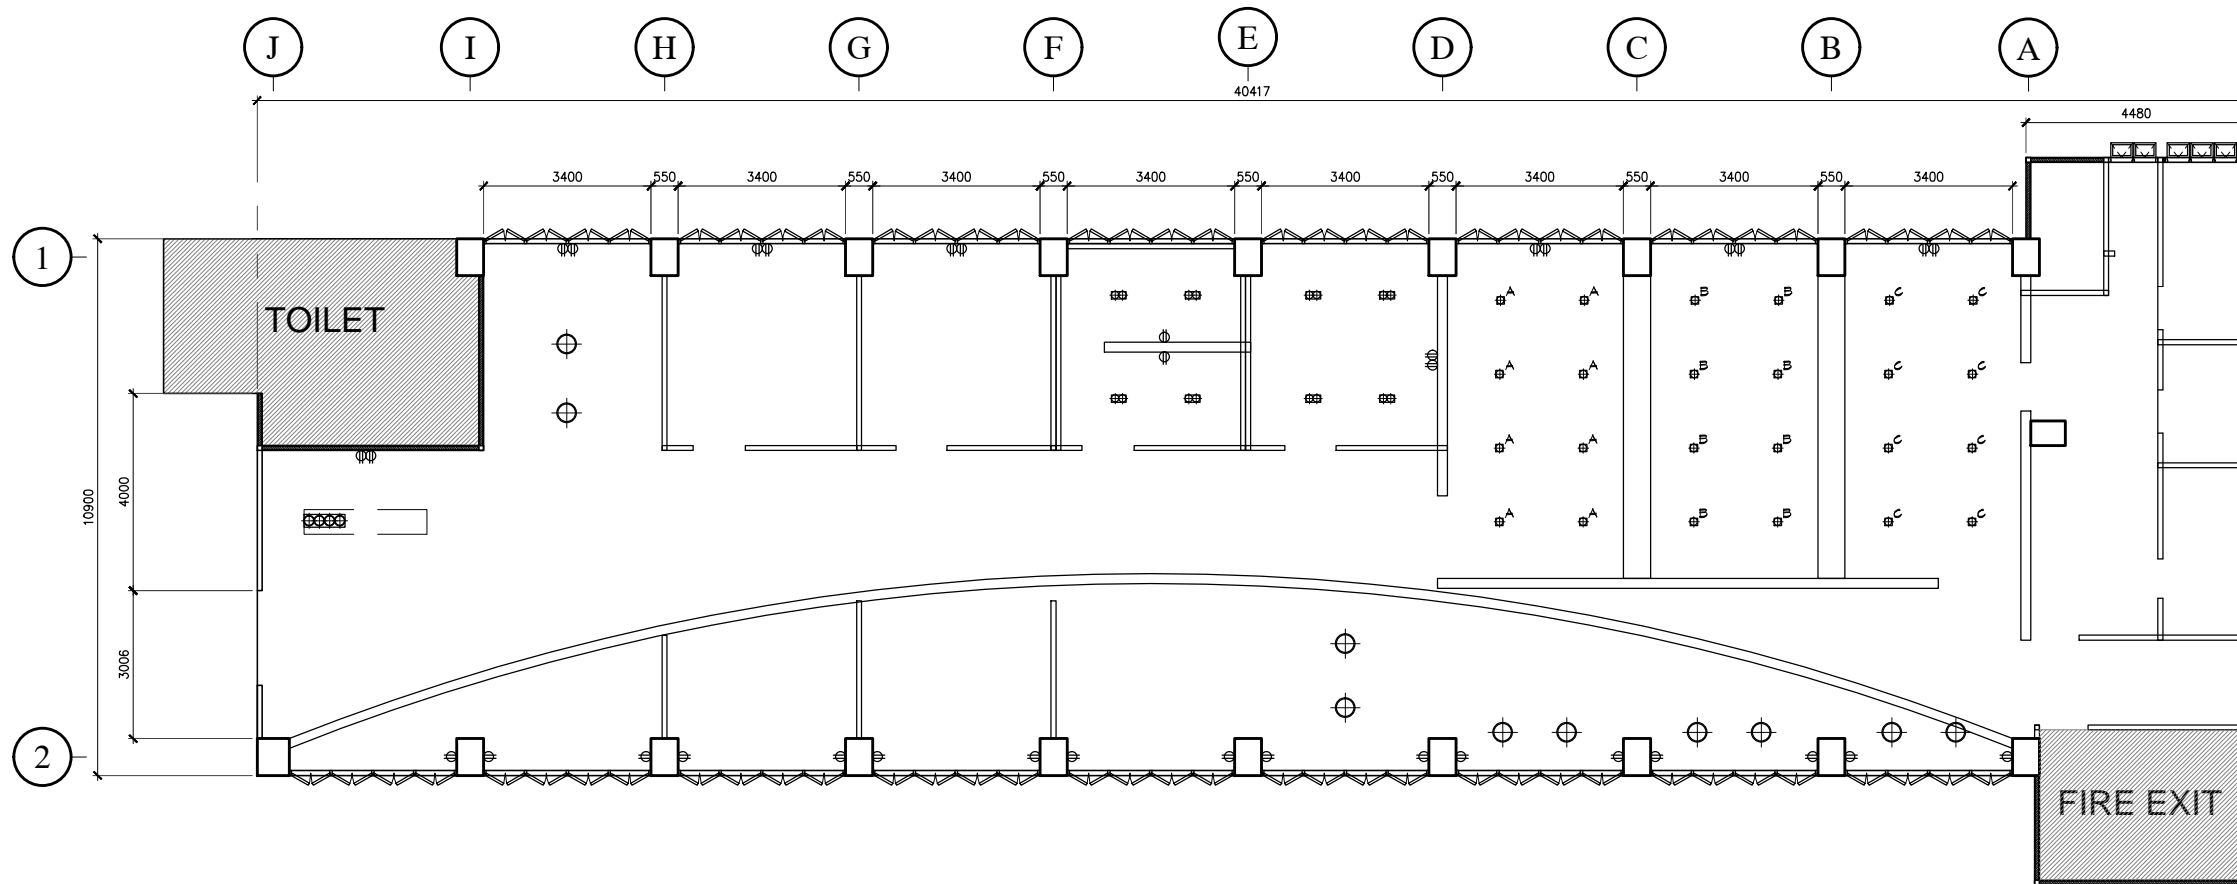

ELECTRICAL LAYOUT PLAN
SCALE 1:150

| | |
|--|---------------------------|
| | โคมไฟ Downlight แบบเดี่ยว |
| | โคมไฟ Downlight แบบคู่ |
| | โคมไฟห้องเพดาน |
| | โคมไฟห้องเพดาน |
| | ตัวรับไฟคู่ |

PROJECT :

NIDA STUDIO

NIDA STUDIO

1 2018 FOR DESIGN CO-ORDINATION 7R

ISSUE DATE DESCRIPTION CHK.

PROJECT NO. : NIDA STUDIO

DESIGNER : Chawalit A.

CHECKED BY :

DRAWN BY : Tipanan P.

DATE :

CAD DWG. FILE :

SCALE :

DRAWING TITLE :

ELECTRICAL LAYOUT PLAN

FOR DESIGN CO-ORDINATION

ISSUE DRAWING NO.

02-1